


LONG SECTION THROUGH UPPER SUDS AREA
SURFACE WATER DRAINAGE MANHOLES SW501 to SW303(B)
HORZ SCALE 1:500; VERT SCALE 1:500

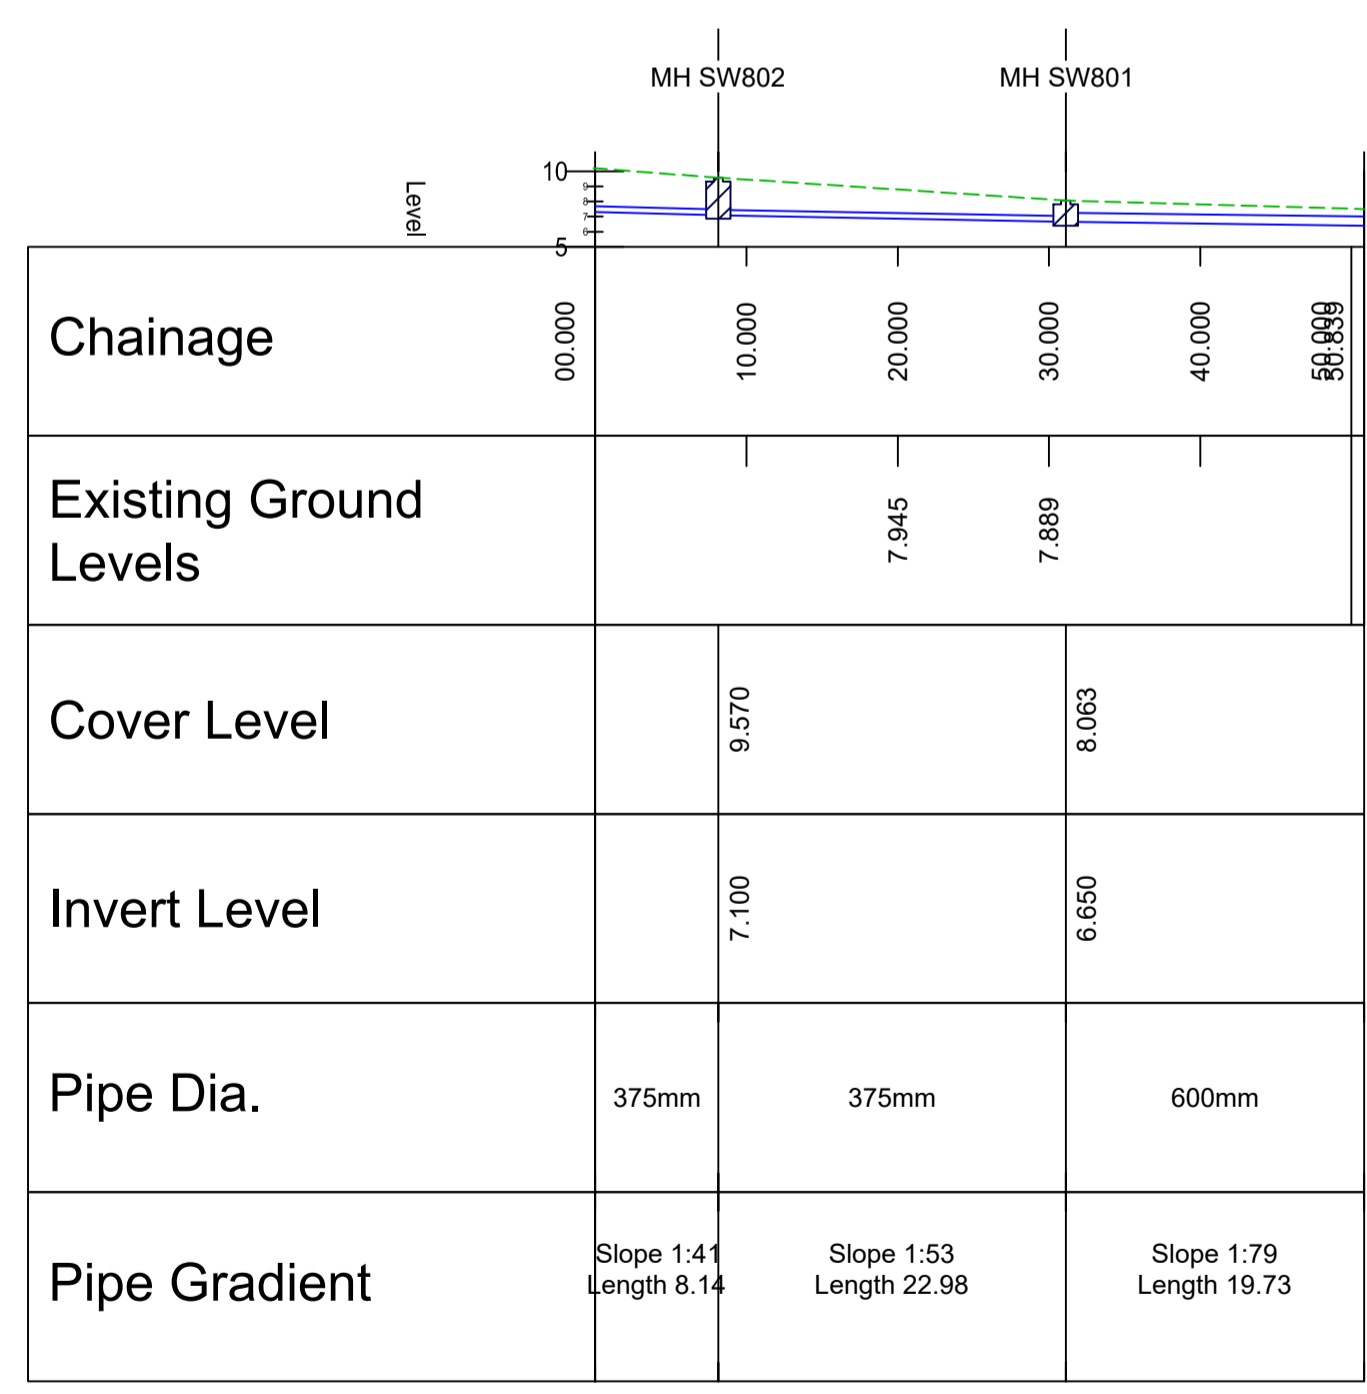

LONG SECTION THROUGH LOWER SUDS AREA
SURFACE WATER DRAINAGE MANHOLES SW802 to SW801
HORZ SCALE 1:500; VERT SCALE 1:500

Notes

- All dimensions are in metres unless noted otherwise.
- All levels are in metres unless noted otherwise.

Key to symbols

----- Proposed Ground Level

----- Proposed Surface Water Drainage

Reference drawings

MMD-409577-C-DR-00-XX-1124 - Foul and Surface Water Drainage Layout - Overall
MMD-409577-C-DR-00-XX-1125-1129 - Foul and Surface Water Drainage Layouts
MMD-409577-C-DR-00-XX-1130 - Foul and Surface Water Drainage Manhole Schedules
MMD-409577-C-DR-00-XX-1210 - Surface Water Sections - North Loch Drive
MMD-409577-C-DR-00-XX-1211 - Surface Water Sections - Spine Road (Sheet 1 of 3)
MMD-409577-C-DR-00-XX-1212 - Surface Water Sections - Spine Road (Sheet 2 of 3)
MMD-409577-C-DR-00-XX-1213 - Surface Water Sections - Spine Road (Sheet 3 of 3)
MMD-409577-C-DR-00-XX-1214 - Surface Water Sections - Upper and Lower Escarpment
MMD-409577-C-DR-00-XX-1215 - Surface Water Sections - Upper and Lower SUDS Areas

P1	01:21	EW	Preliminary Issue	JM	KB
Rev	Date	Drawn	Description	Ch'k'd	App'd

MOTT MACDONALD

Greenhead
Lerwick
Shetland
ZE1 0PY
United Kingdom
T +44 (0)1595 695049
F
W mottmac.com

Client

Hjaltrand Housing Association Ltd
2 Harbour Street
Lerwick
Shetland
ZE1 0LR

Title

Proposed Housing at Staneyhill, Lerwick
Work Stream 1 - Civils Infrastructure

Long Sections Through Upper and Lower
SUDS Areas Surface Water Drainage

Designed	P Richardson	PR	Eng check	J Moncrieff	JM
Drawn	E Wishart	EW	Coordination	J Moncrieff	JM
Dwg check	J Moncrieff	JM	Approved	K Burnett	KB
Scale at A1	Status	Rev	Security		
1:500	PRE	P1	STD		

Drawing Number

MMD-409577-C-DR-00-XX-1215

