


LONG SECTION THROUGH UPPER ESCARPMENT ROAD
FOUL SEWER DRAINAGE MANHOLES FW501 to FW604
HORZ SCALE 1:500; VERT SCALE 1:500

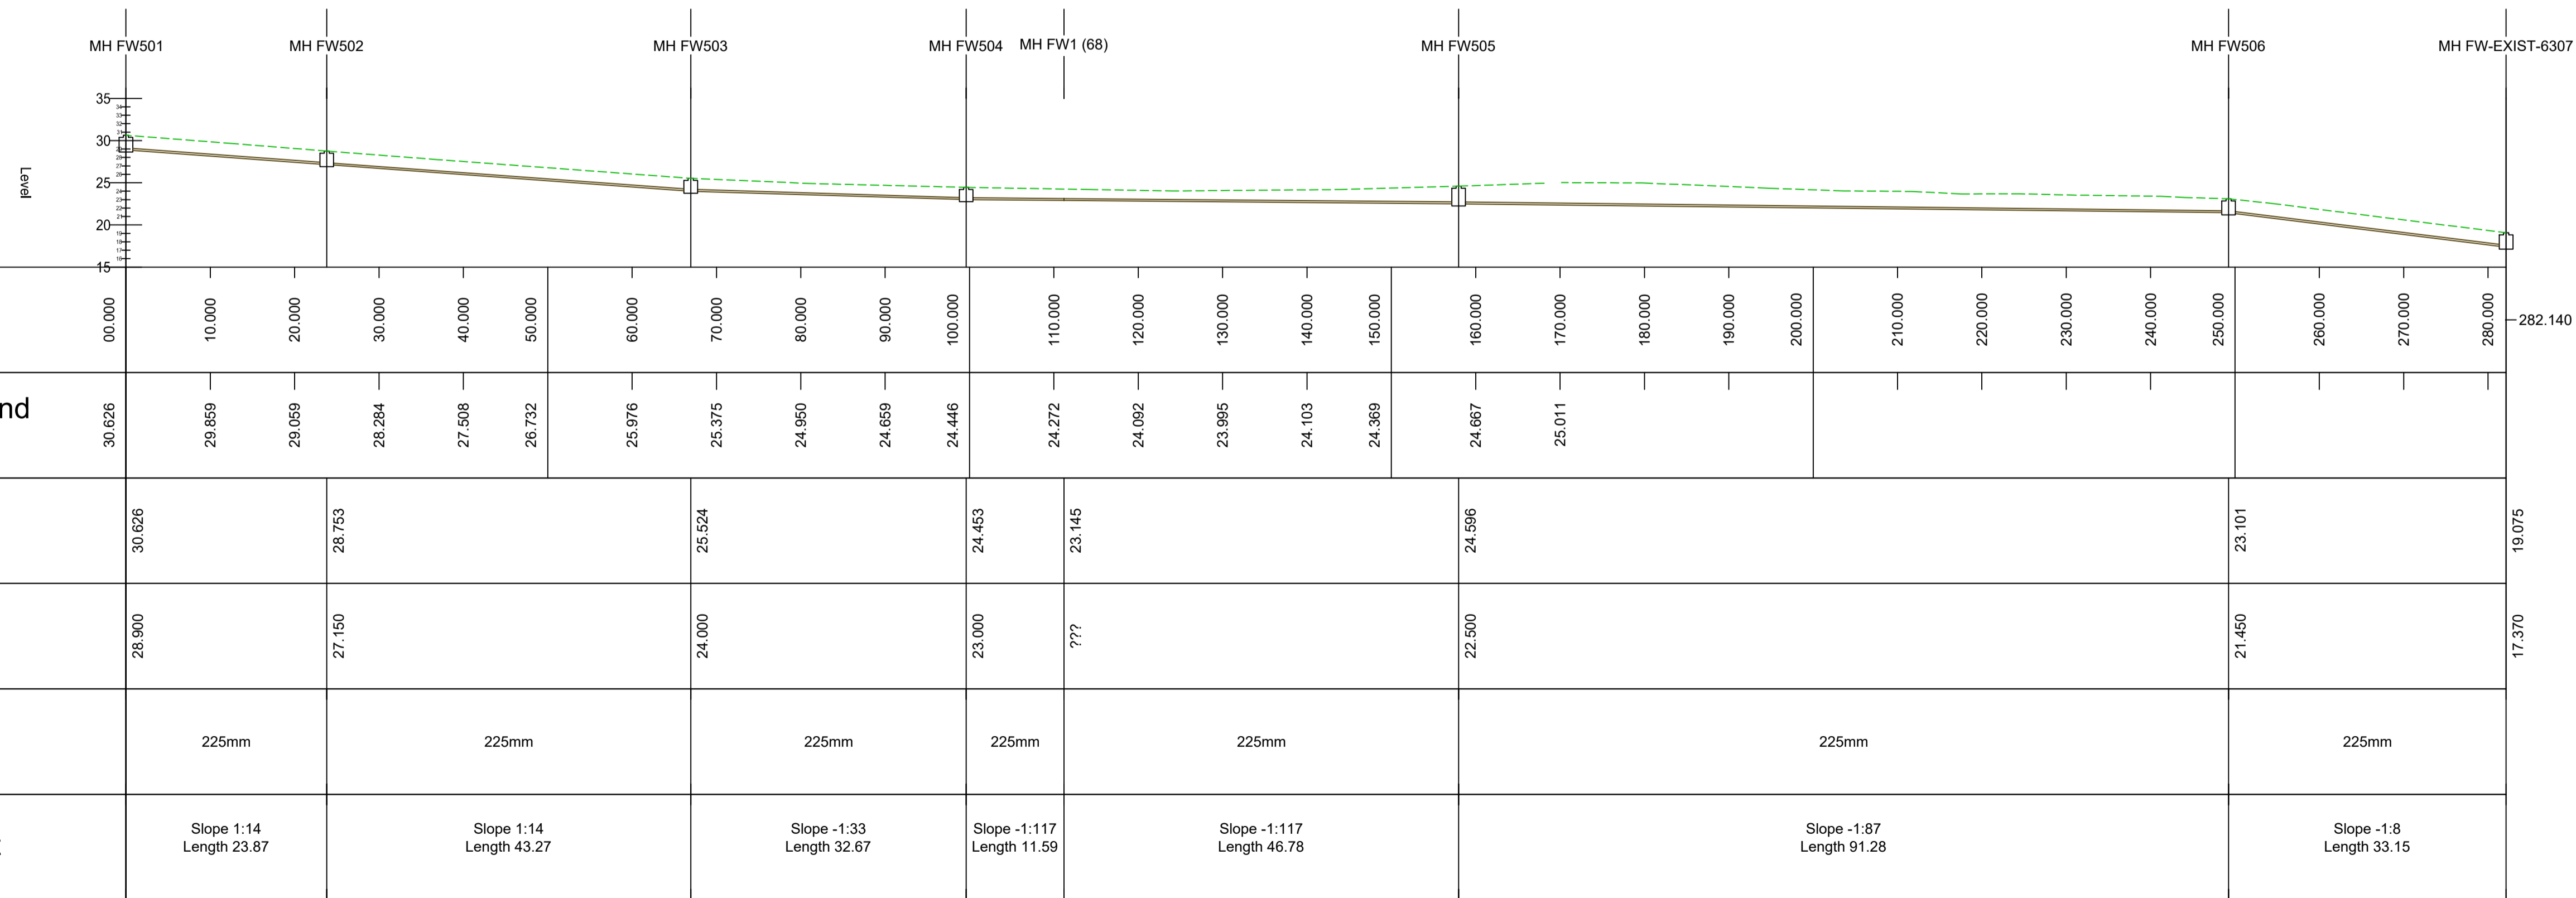

LONG SECTION THROUGH LOWER ESCARPMENT ROAD
FOUL SEWER DRAINAGE MANHOLES FW501 to FW-EXIST 6307
HORZ SCALE 1:500; VERT SCALE 1:500

Notes

- All dimensions are in metres unless noted otherwise.
- All levels are in metres unless noted otherwise.

Key to symbols

----- Proposed Ground Level

----- Proposed Foul Sewer Drainage

Reference drawings

MMD-409577-C-DR-00-XX-1124 - Foul and Surface Water Drainage Layout - Overall
MMD-409577-C-DR-00-XX-1125-1129 - Foul and Surface Water Drainage Layouts
MMD-409577-C-DR-00-XX-1130 - Foul and Surface Water Drainage Manhole Schedules

P1	01:21	EW	Preliminary Issue	JM	KB
Rev	Date	Drawn	Description	Ch'k'd	App'd

MOTT MACDONALD

Greenhead
Lerwick
Shetland
ZE1 0PY
United Kingdom
T +44 (0)1595 695049
F
W mottmac.com

Client

Hjaltrand Housing Association Ltd
2 Harbour Street
Lerwick
Shetland
ZE1 0LR

Title

Proposed Housing at Staneyhill, Lerwick
Work Stream 1 - Civils Infrastructure

Long Sections Through Upper and Lower
Escarpment Roads Foul Sewer Drainage

Designed	P Richardson	PR	Eng check	J Moncrieff	JM
Drawn	E Wishart	EW	Coordination	J Moncrieff	JM
Dwg check	J Moncrieff	JM	Approved	K Burnett	KB
Scale at A1	Status	Rev	Security		
1:500	PRE	P1	STD		
Drawing Number					
MMD-409577-C-DR-00-XX-1219					

