


LONG SECTION THROUGH UPPER ESCARPMENT ROAD  
SURFACE WATER DRAINAGE MANHOLES SW501 to SW504  
HORZ SCALE 1:500; VERT SCALE 1:500

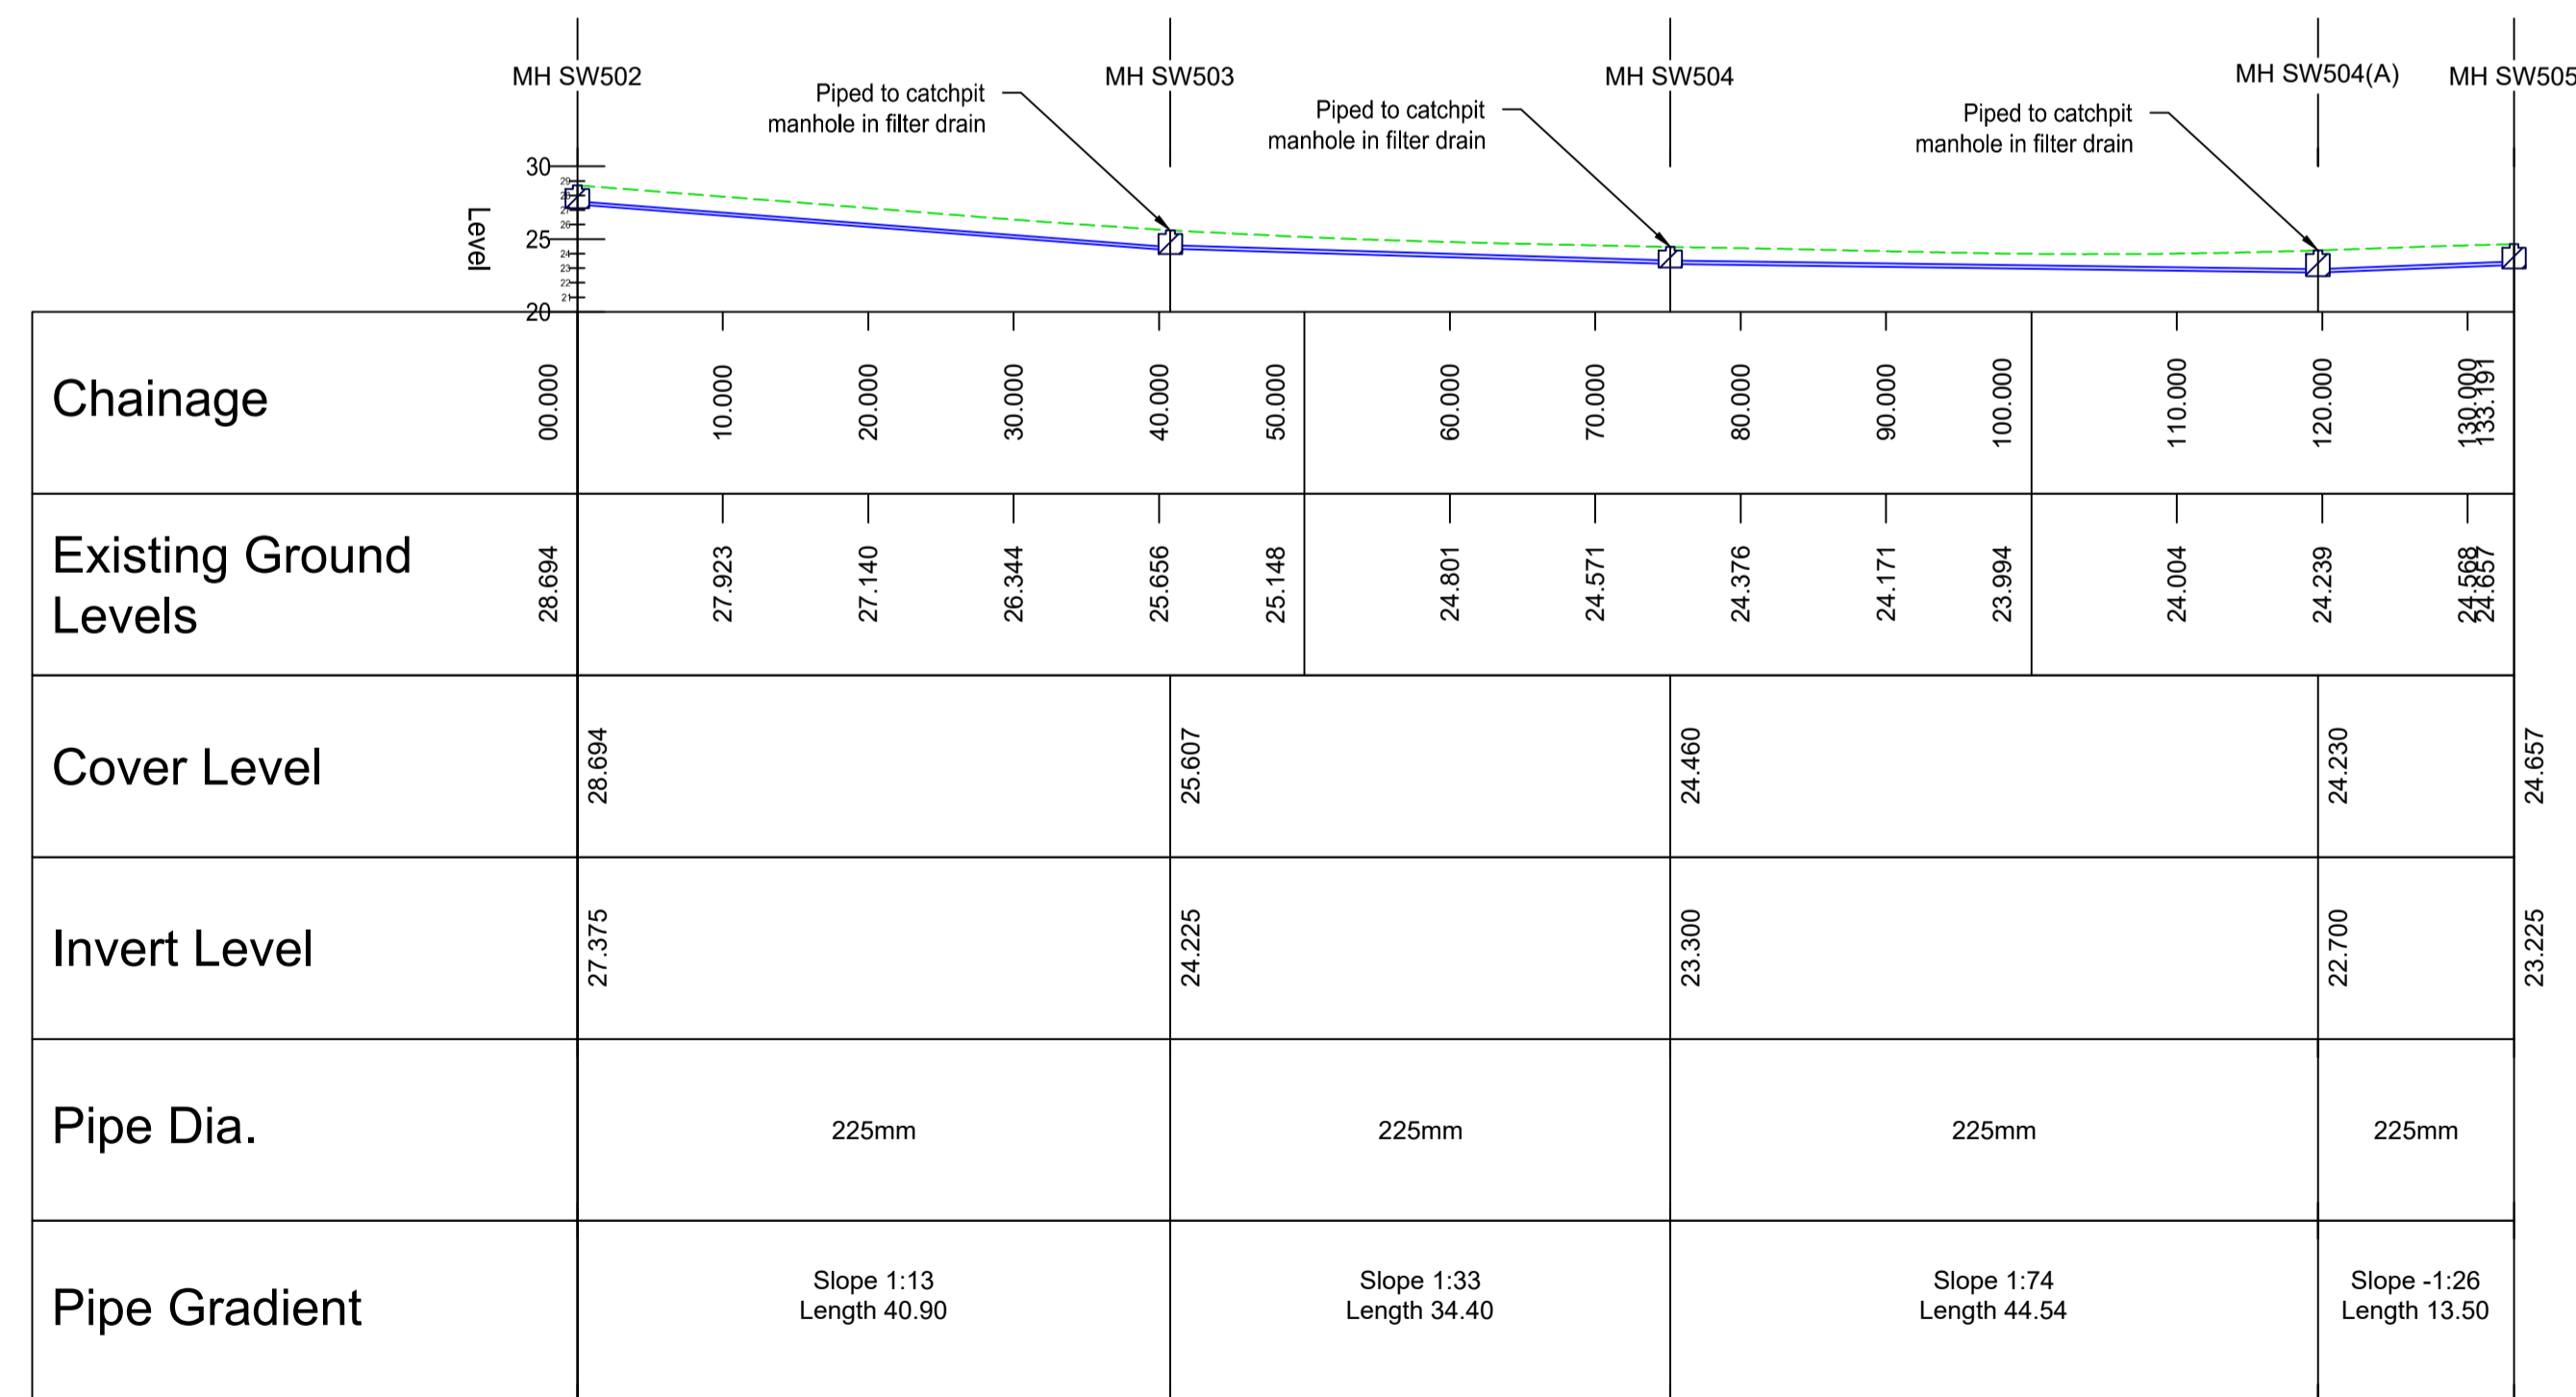

LONG SECTION THROUGH UPPER ESCARPMENT ROAD  
SURFACE WATER DRAINAGE MANHOLES SW502 to SW504  
HORZ SCALE 1:500; VERT SCALE 1:500

Notes

- All dimensions are in metres unless noted otherwise.
- All levels are in metres unless noted otherwise.

Key to symbols

----- Proposed Ground Level

----- Proposed Surface Water Drainage

Reference drawings

MMD-409577-C-DR-00-XX-1124 - Foul and Surface Water Drainage Layout - Overall  
MMD-409577-C-DR-00-XX-1125-1129 - Foul and Surface Water Drainage Layouts  
MMD-409577-C-DR-00-XX-1130 - Foul and Surface Water Drainage Manhole Schedules  
MMD-409577-C-DR-00-XX-1210 - Surface Water Sections - North Loch Drive  
MMD-409577-C-DR-00-XX-1211 - Surface Water Sections - Spine Road (Sheet 1 of 3)  
MMD-409577-C-DR-00-XX-1212 - Surface Water Sections - Spine Road (Sheet 2 of 3)  
MMD-409577-C-DR-00-XX-1213 - Surface Water Sections - Spine Road (Sheet 3 of 3)  
MMD-409577-C-DR-00-XX-1214 - Surface Water Sections - Upper and Lower Escarpment  
MMD-409577-C-DR-00-XX-1215 - Surface Water Sections - Upper and Lower SUDS Areas

P1	01:21	EW	Preliminary Issue	JM	KB
Rev	Date	Drawn	Description	Ch'k'd	App'd

**MOTT MACDONALD**

Greenhead  
Lerwick  
Shetland  
ZE1 0PY  
United Kingdom  
T +44 (0)1595 695049  
F  
W mottmac.com

Client

Hjaltrand Housing Association Ltd  
2 Harbour Street  
Lerwick  
Shetland  
ZE1 0LR

Title

Proposed Housing at Staneyhill, Lerwick  
Work Stream 1 - Civils Infrastructure

Long Sections Through Upper and Lower  
Escarpment Roads Surface Water Drainage

Designed	P Richardson	PR	Eng check	J Moncrieff	JM
Drawn	E Wishart	EW	Coordination	J Moncrieff	JM
Dwg check	J Moncrieff	JM	Approved	K Burnett	KB
Scale at A1	Status	Rev	Security		
1:500	PRE	P1	STD		
Drawing Number					
MMD-409577-C-DR-00-XX-1214					

